


E.447700

N.108100

N.108000

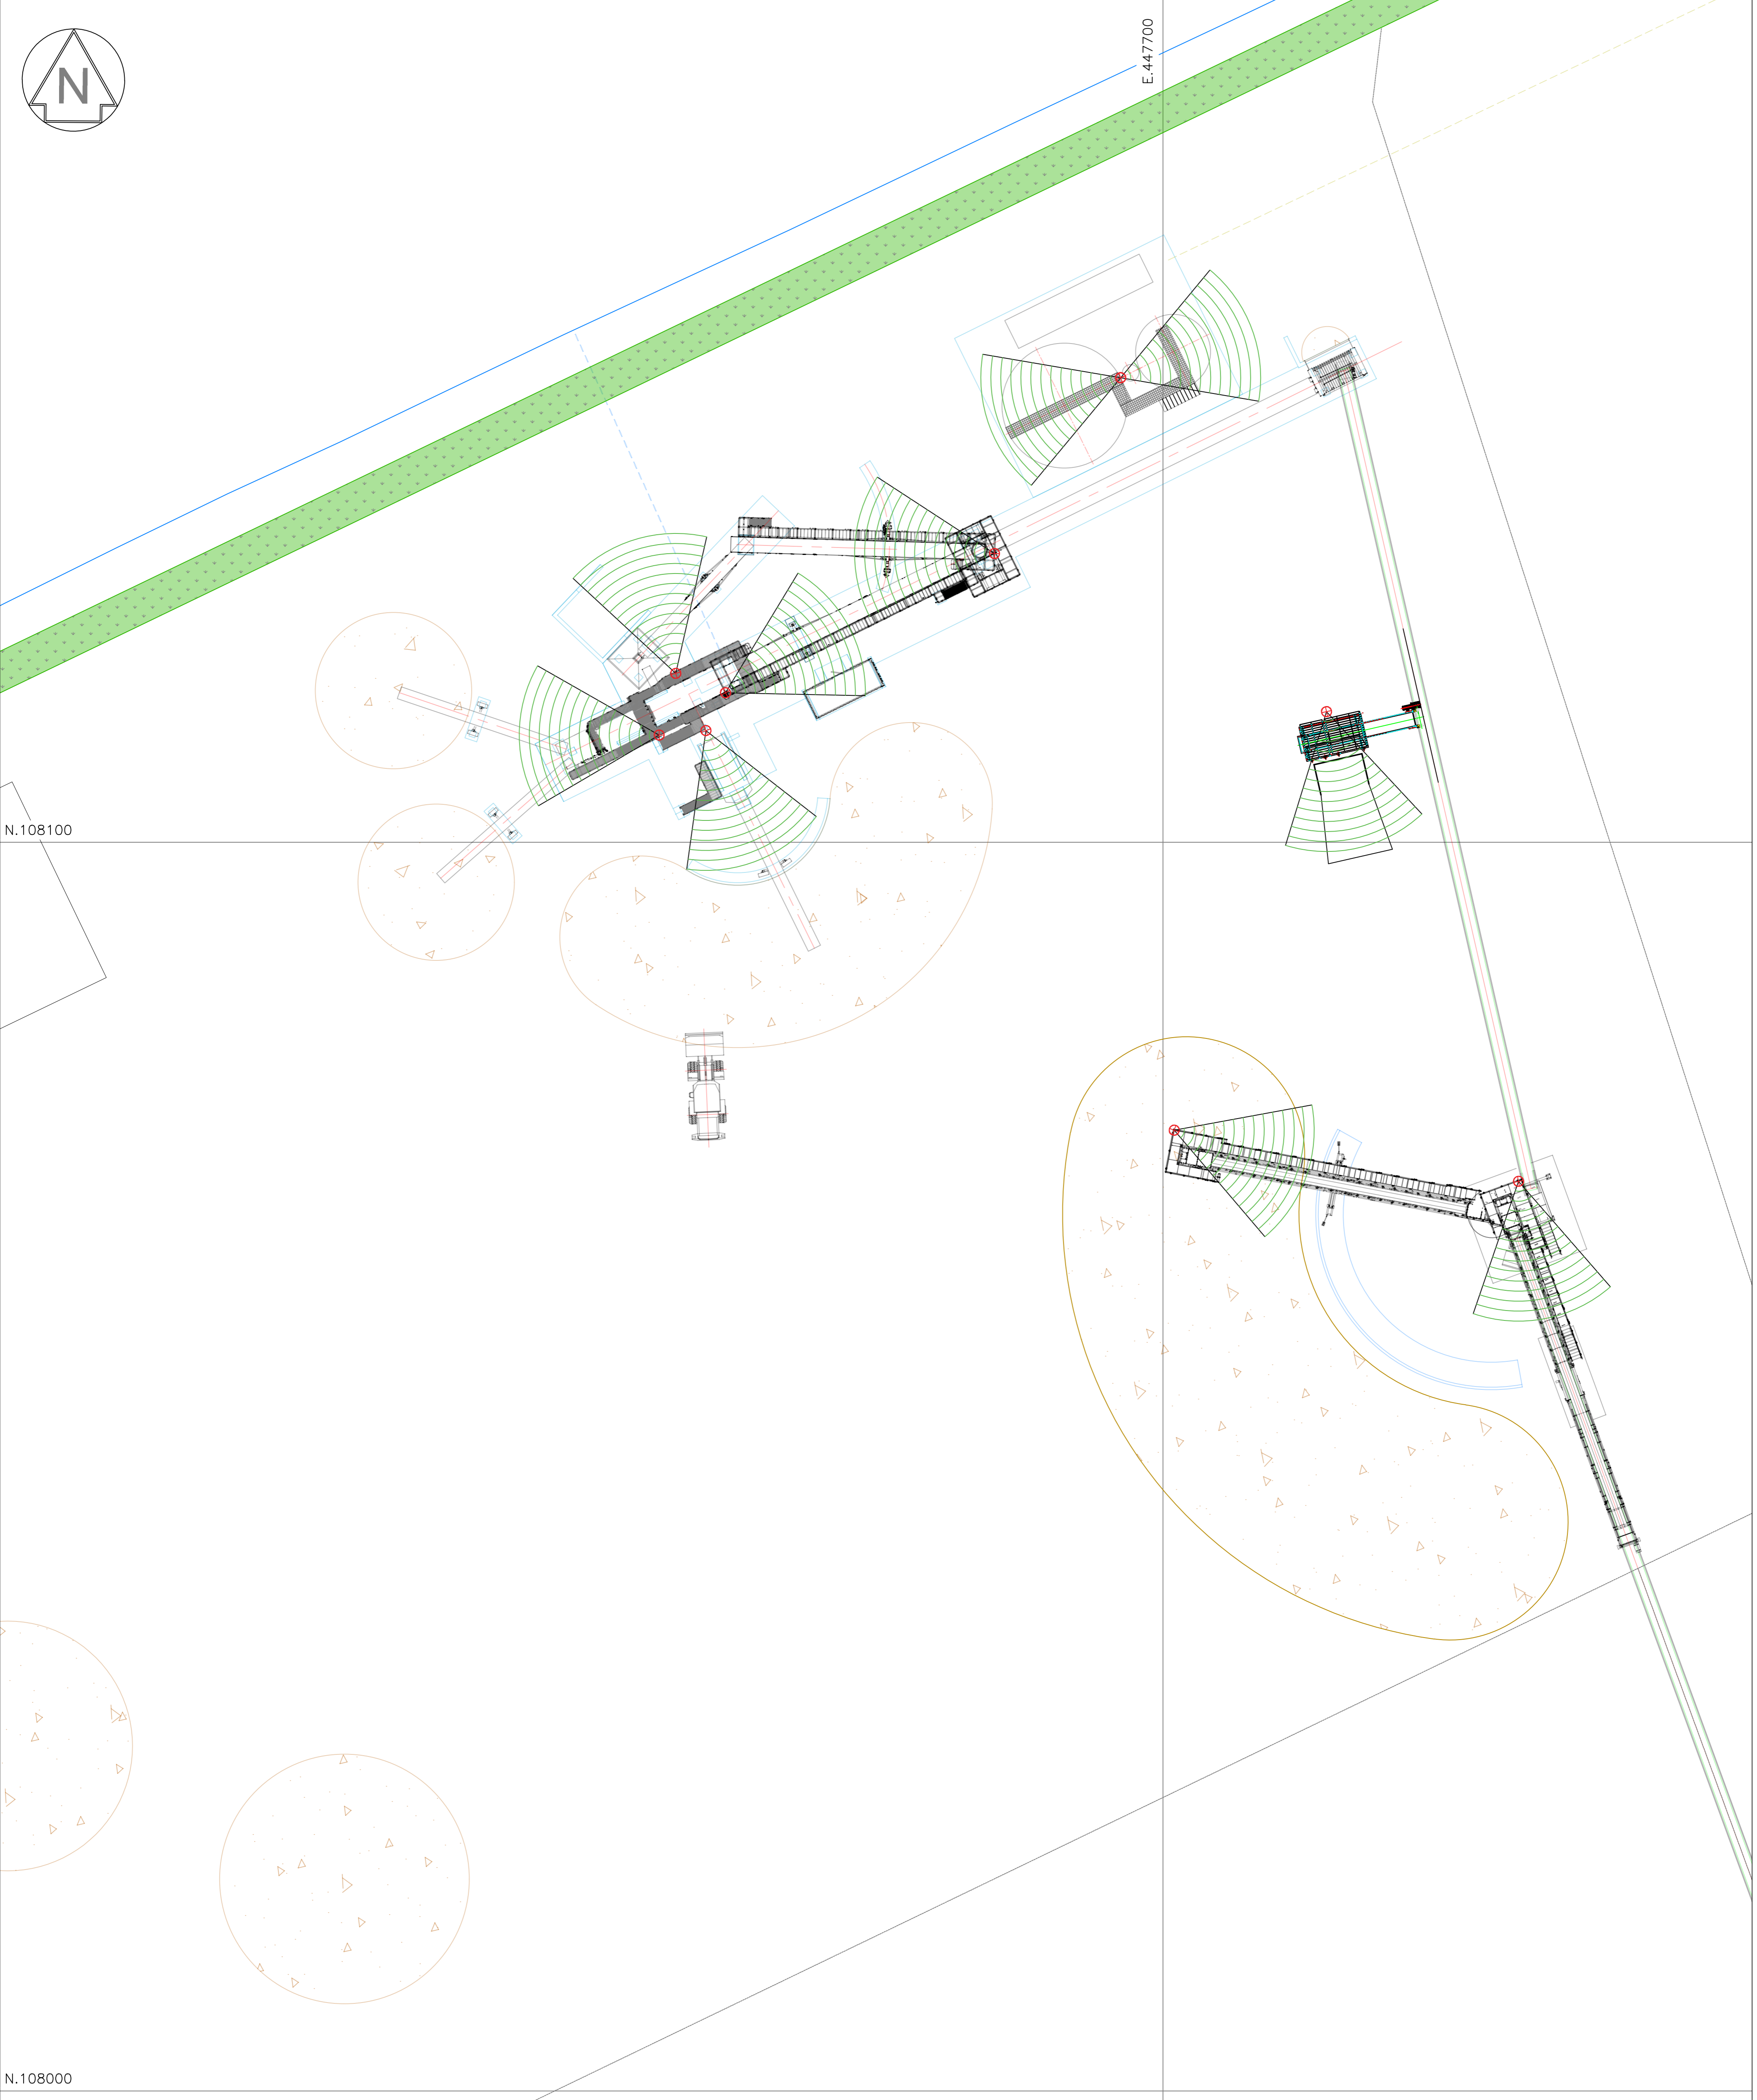

**KEY**

EQUIPMENT MOUNTED LED  
(HEIGHT VARIES) 10 TOTAL

Revisions			
B	GENERALLY UPDATED	07DEC21	MJH
A	UPDATED TO REFLECT REVISED SITE LAYOUT	04NOV21	MJH
C	ORIGINAL		

Based on Ordnance Survey Land Line data with the permission of Her Majesty's Stationery Office, © Crown copyright, Licence N° 100018131

**ENGINEERING SERVICES**  
CEMEX UK Operations Limited  
CEMEX House, Eveux Way,  
Rugby, Warwickshire,  
CV21 2DT

Telephone 01788 542111  
Facsimile 01788 564455

Drawn By	MJH	Company	CEMEX UK MATERIALS LIMITED
Date	04 OCT 2021	Site	HAMBLE QUARRY
Scale(s)	1:250 @ A1	Project	AGGREGATE PROCESSING PLANT
Check/Model(s)	AG	File	LIGHTING LAYOUT - AGGREGATE PROCESSING PLANT AREA
Site Ref.	XXXXXX	Drawing No.	TD 21045
		SHT 2 OF 2	Rev B

The information contained in this drawing is the property of CEMEX. It should not be reproduced partially or totally without written authorisation from CEMEX