


E.447700


N.108100

N.108000

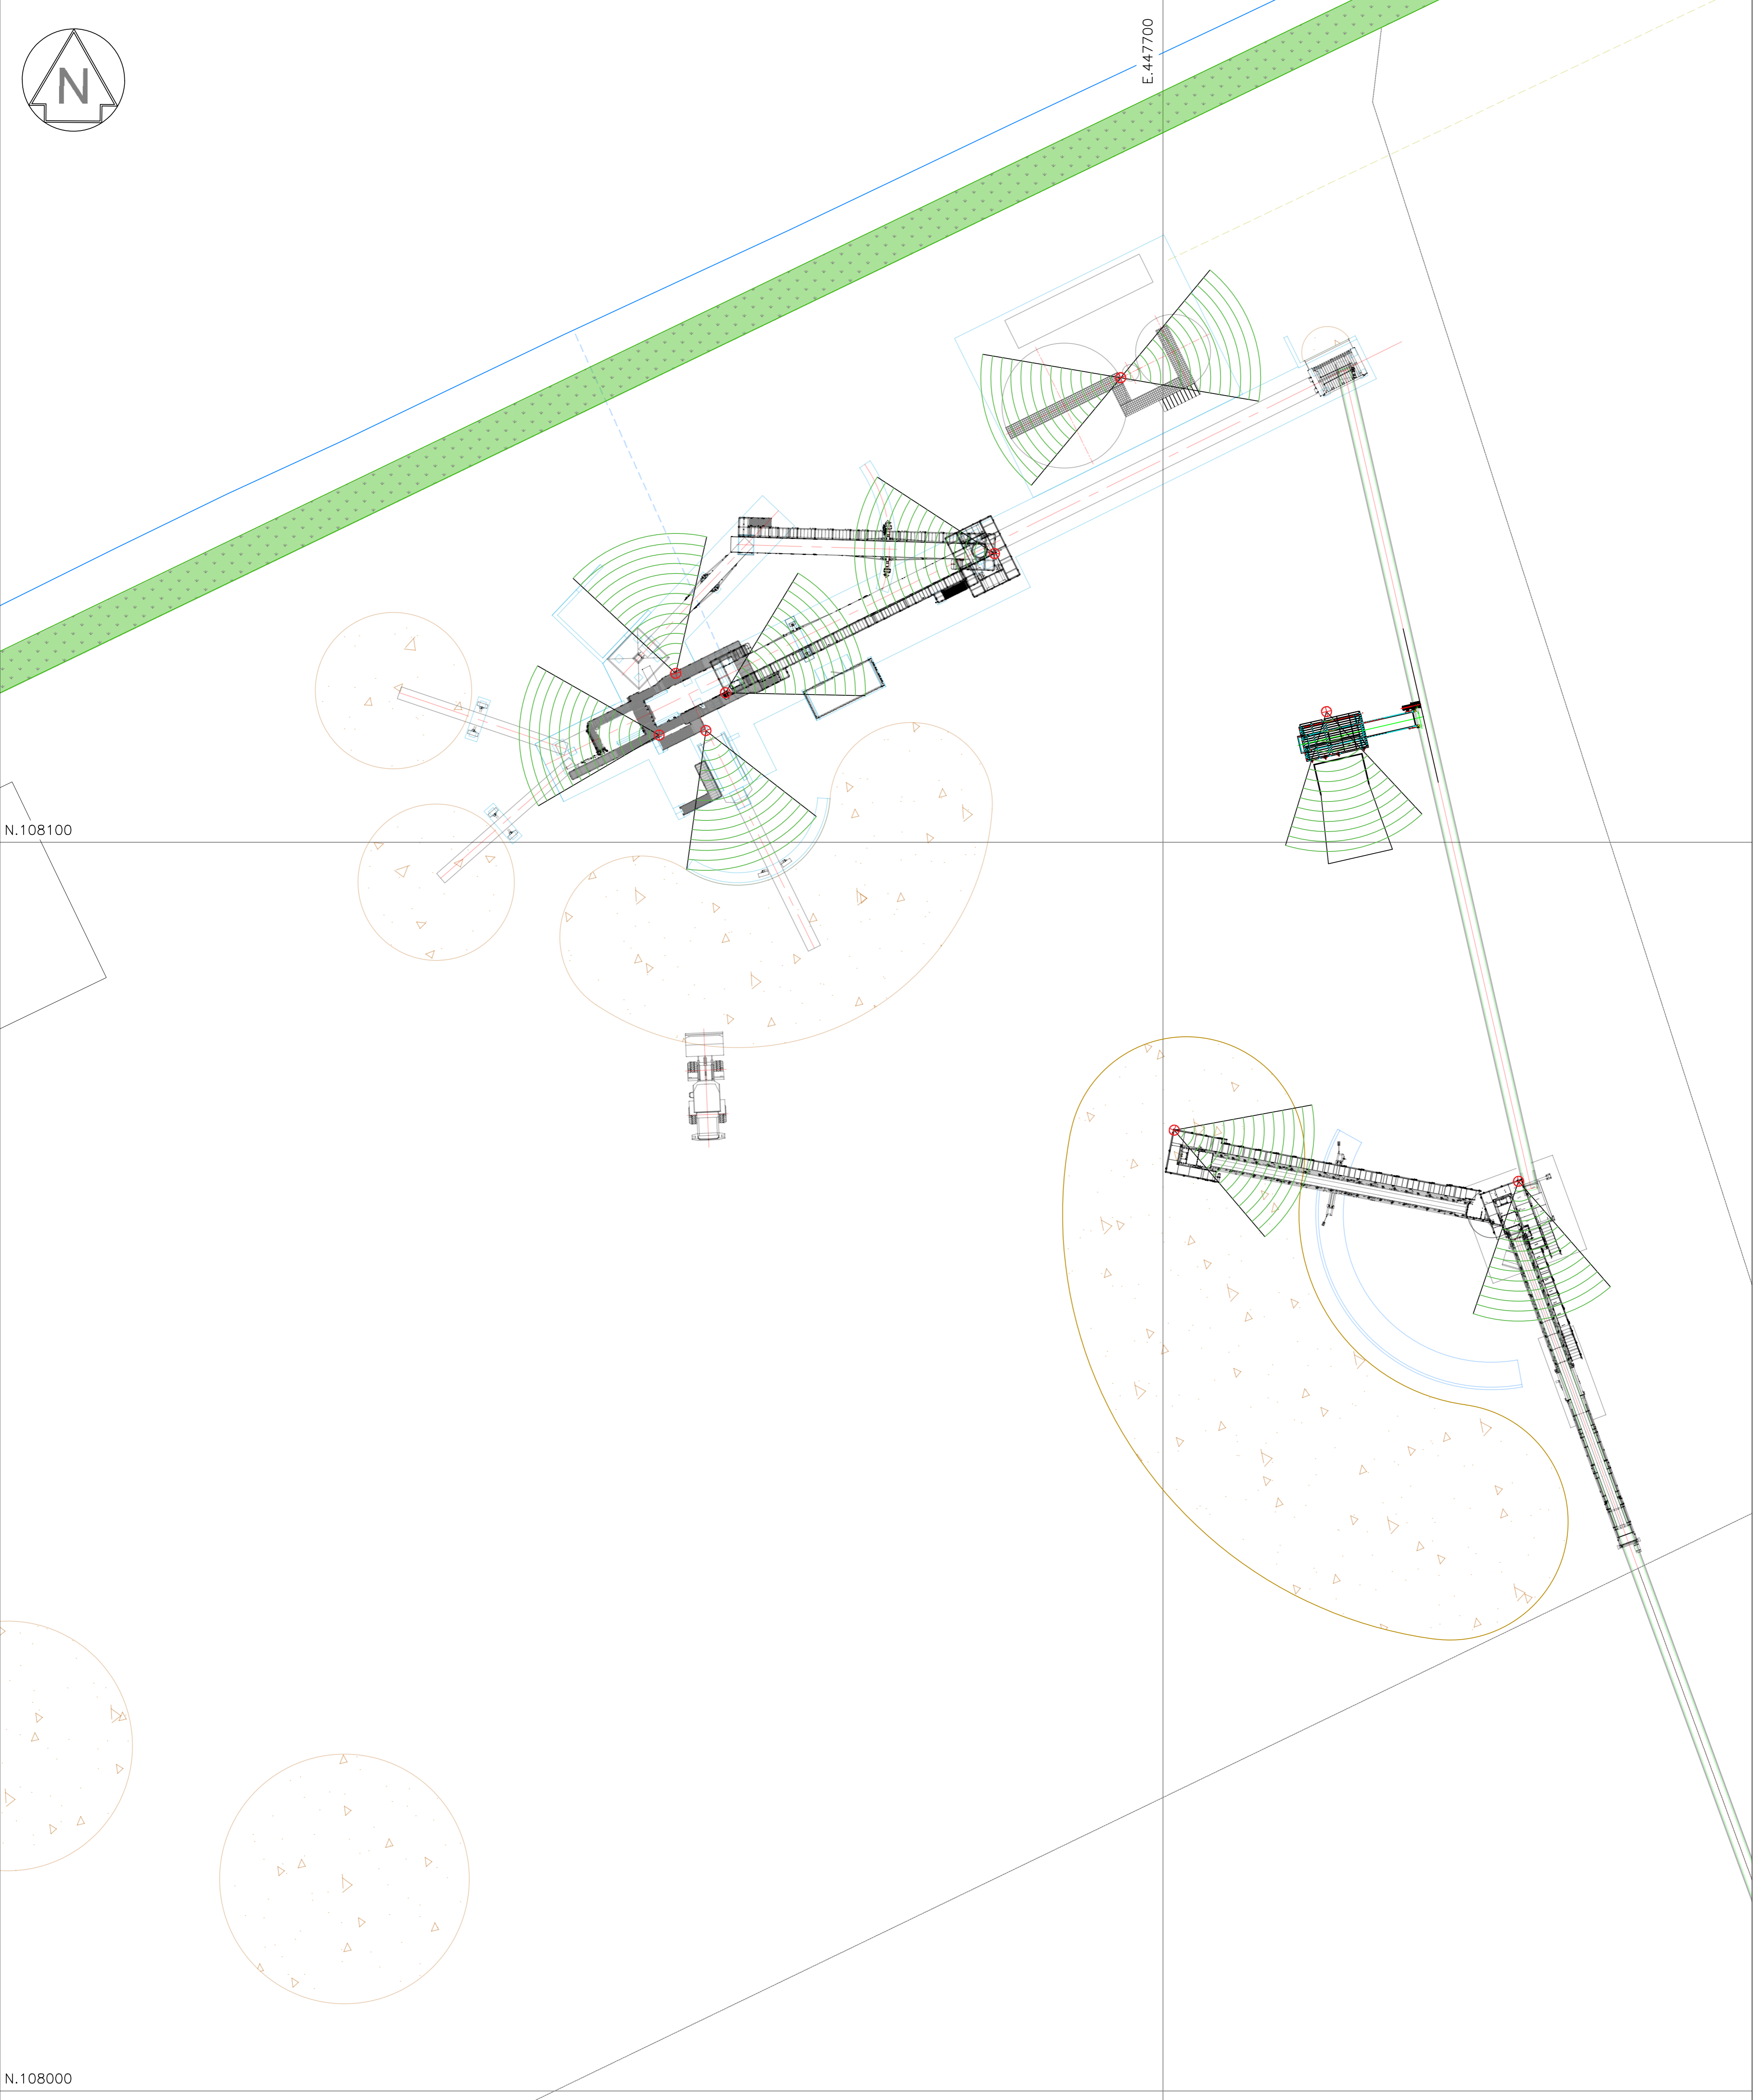

KEY

EQUIPMENT MOUNTED LED
(HEIGHT VARIES) 10 TOTAL

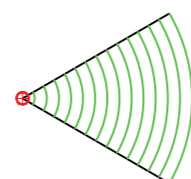

Revisions			
C	SITE ENTRANCE LOCATION ADJUSTED	03OCT23	MJH
B	GENERALLY UPDATED	07OCT21	MJH
A	UPDATED TO REFLECT REVISED SITE LAYOUT	04NOV21	MJH
D	ORIGINAL	DATE	DRAWN

Based on Ordnance Survey Land Line data with the permission of Her Majesty's Stationery Office, © Crown copyright, Licence N° 100018131

CEMEX
ENGINEERING SERVICES
 CEMEX UK Operations Limited
 CEMEX House, Eveux Way,
 Rugby, Warwickshire,
 CV21 2DT
 Telephone 01788 542111
 Facsimile 01788 564455

Drawn By	Company
MJH	CEMEX UK MATERIALS LIMITED

Date	Site
04 OCT 2021	HAMBLE QUARRY

Scale(s)	Project
1:250 @ A1	AGGREGATE PROCESSING PLANT

Check/Model(s)	File
AG	LIGHTING LAYOUT - AGGREGATE PROCESSING PLANT AREA

Site Ref.	Drawing No.	SHT 2 OF 2	Rev
XXXXX	TD 21045		C

The information contained in this drawing is the property of CEMEX. It should not be reproduced partially or totally without written authorisation from CEMEX